




**WARNING**  
BEWARE OF EXISTING UNDERGROUND SERVICES.  
CONTRACTOR SHALL CONFIRM LOCATIONS OF SERVICES  
PRIOR TO EXCAVATION. COORDINATE WITH  
ALL RELEVANT AUTHORITIES.

**GIFTED ASSETS**

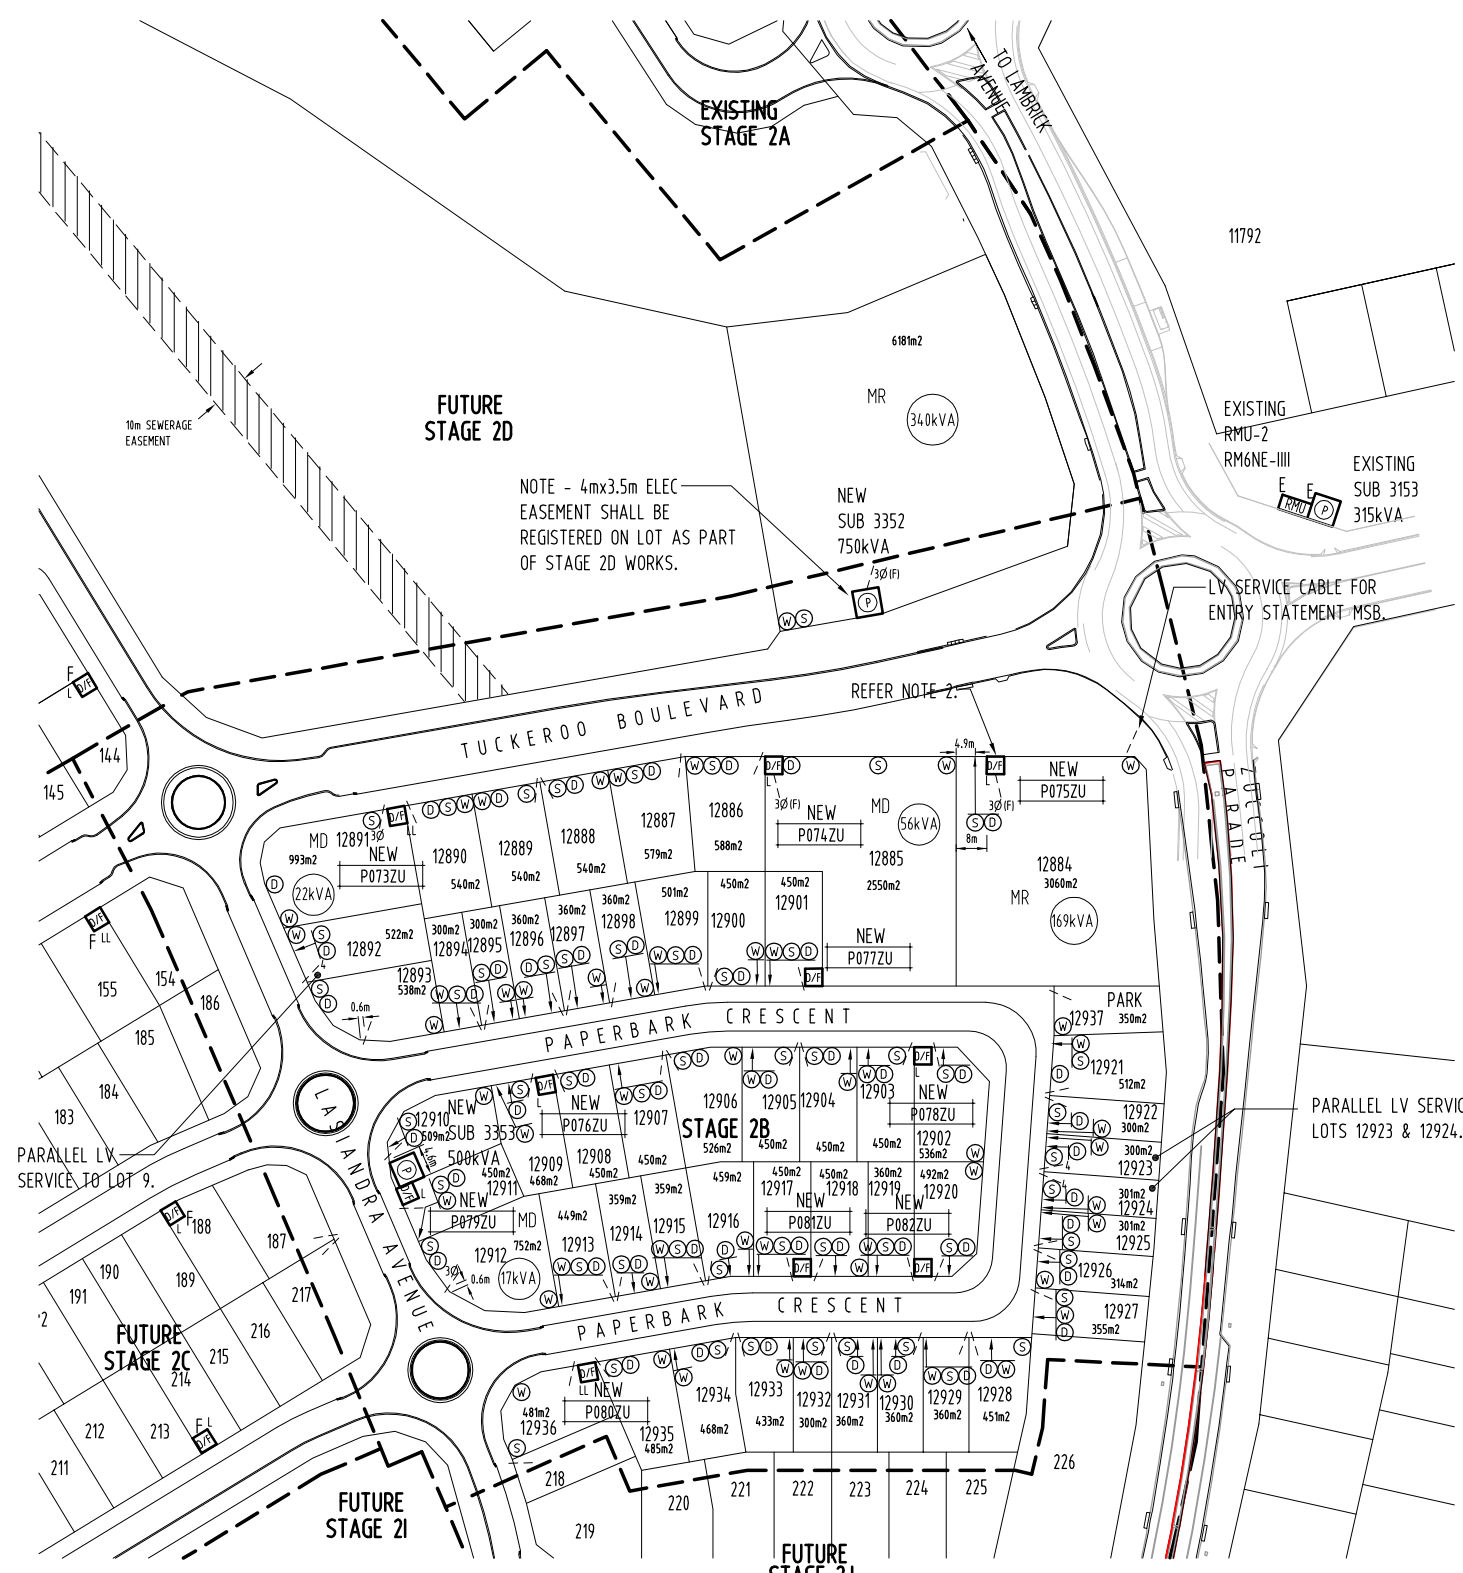

NOTE - 4mx3.5m ELEC EASEMENT SHALL BE REGISTERED ON LOT AS PART OF STAGE 2D WORKS.


**SITE PLAN** (1:1000 AT A1)

**LEGEND**

- EXISTING RING MAIN UNIT.
- PACKAGE SUBSTATION (RATING AS SHOWN). 'E' INDICATES EXISTING.
- DISTRIBUTION DOUBLE LINK PILLAR - FUSED TYPE. 'F' INDICATES FUTURE.
- DISTRIBUTION LINK PILLAR - FUSED TYPE. 'F' INDICATES FUTURE.
- DISTRIBUTION PILLAR - FUSED TYPE.
- LV SERVICE CABLE/CONNECTION.
- PARALLEL LV SERVICE CABLE/CONNECTION.
- 3 PHASE LV SERVICE CABLE/CONNECTION.
- FUTURE 3 PHASE CONSUMER MAINS - BY LOT OWNER.
- WATER CONNECTION.
- SEWER CONNECTION.
- DRAINAGE CONNECTION.

**NOTES**

- 1 - REFER DWG No. B14-13180 FOR DETAILS OF ITEMS LISTED IN LEGEND (EXCLUDING WATER/SEWER/DRAINAGE CONNECTION).
- 2 - LOT 12884 ELECTRICITY EASEMENT SHALL BE 4mx3.5m TO ALLOW FOR POSSIBLE FUTURE PACKAGE SUBSTATION.

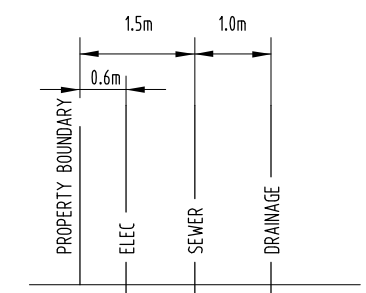

**DETAIL E - TYPICAL SERVICE CONNECTION WHERE ELEC/SEWER/DRAINAGE IN SAME LOT CORNER (N.T.S.)**

CONTRACTOR:  
**NORTHERN POWER SERVICES**  
PO BOX 1844  
PALMERSTON NT 0831  
  
PHONE: 8932 9317  
FACSIMILE: 8932 9346

DEVELOPER:  
**TERRITORY LIFE**  
  
GPO Box 1782  
DARWIN NT 0801  
  
PHONE: 8943 0641  
FACSIMILE: 8941 0848  
EMAIL: [tlouw@nspgm.com.au](mailto:tlouw@nspgm.com.au)  
CONTACT: HERMANUS LOUW

**AGA CONSULTING ENGINEERS PTY LTD ELECTRICAL & MECHANICAL**  
ACN 070 242 296  
  
GPO BOX 3097  
DARWIN NT 0801  
  
TELEPHONE: 08 89416582  
FACSIMILE: 08 89421400  
EMAIL: [aleky@agaeng.com.au](mailto:aleky@agaeng.com.au)

NO	DESCRIPTION	DRN	DATE	APPD	DRG NO	TITLE
G	AS CONSTRUCTED		K.T.	28-4-15	A.G.	
F	RE-ISSUED FOR CONSTRUCTION		K.T.	29-4-15	A.G.	
E	LAYOUT AMENDED		K.T.	15-1-15	A.G.	
D	ISSUED FOR CONSTRUCTION		K.T.	5-1-15	A.G.	
C	LAYOUT & NOTES AMENDED		K.T.	18-12-14	A.G.	
B	ISSUED FOR POWER AND WATER APPROVAL		K.T.	1-12-14	A.G.	
A	ISSUED FOR POWER AND WATER REVIEW		K.T.	17-11-14	A.G.	

DRAWING STATUS	APPD	DATE
P PRELIMINARY/PROPOSED		
T TENDERING PURPOSES ONLY		
AC APP. FOR CONSTRUCTION		
AI AS INSTALLED		
C CANCELLED/SUPERSEDED		



DES	A.GANGUR	<b>POWER NETWORKS - PALMERSTON DISTRIBUTION SUBDIVISION OF LOT 12087</b>
DRN	K.TAVENER	
CKD	A.GANGUR	
APPD	A.GANGUR	<b>ZUCCOLI SUBDIVISION - STAGE 2 : STAGE 2B MASTER SERVICES PLAN</b>
SCALE	1:1000 AT A1	
ISSUED	28-4-15	
ALL DIM. IN mm	A1	<b>DRAWING NUMBER B14-13179</b>
DRAFTING STANDARD TO A.S.1100		FILE No: NE590/12087

